


1 2 3 4 5 6 7 8

Released	Checked by	Approved by	Date
	charjak	dlcappal	dlcgrays

SECONDARY AIR DUCTING ISOMETRIC DRAWING REFERENCES		
DUCT LINE NO.	DUCT DRAWING NO.	P & ID NO.
SEA-1622-48x50A1-B01	P00066710	P00028043
SEA-1638-48x50A1-B01	P00066710	P00028043
SEA-1618-114x308A1-B01	P00066713	P00028043
SEA-1618-76x114A1-B02	P00066713	P00028043
SEA-1631-114x308A1-B01	P00066716	P00028043
SEA-1631-76x114A1-B02	P00066716	P00028043
SEA-1621-48x50A1-B01	P00066719	P00028043
SEA-1637-48x50A1-B01	P00066719	P00028043
SEA-1623-48x66A1-B01	P00066721	P00028043
SEA-1624-48x50A1-B01	P00066724	P00028043
SEA-1625-36x63A1-B01	P00066724	P00028043
SEA-1633-48x66A1-B01	P00066727	P00028043
SEA-1634-48x50A1-B01	P00066730	P00028043
SEA-1643-36x63A1-B01	P00066730	P00028043
SEA-1600-98.5x98.5A1-B01	P00066754	P00028040
SEA-1600-140x140A1-B02	P00066754	P00028040
SEA-1614-140x140A1-B01	P00066754	P00028040
SEA-1614-105x106A1-B02	P00066754	P00028040
SEA-1649-63.5x611A1-B01	P00066752	P00028043

F
E
D
C
B
A

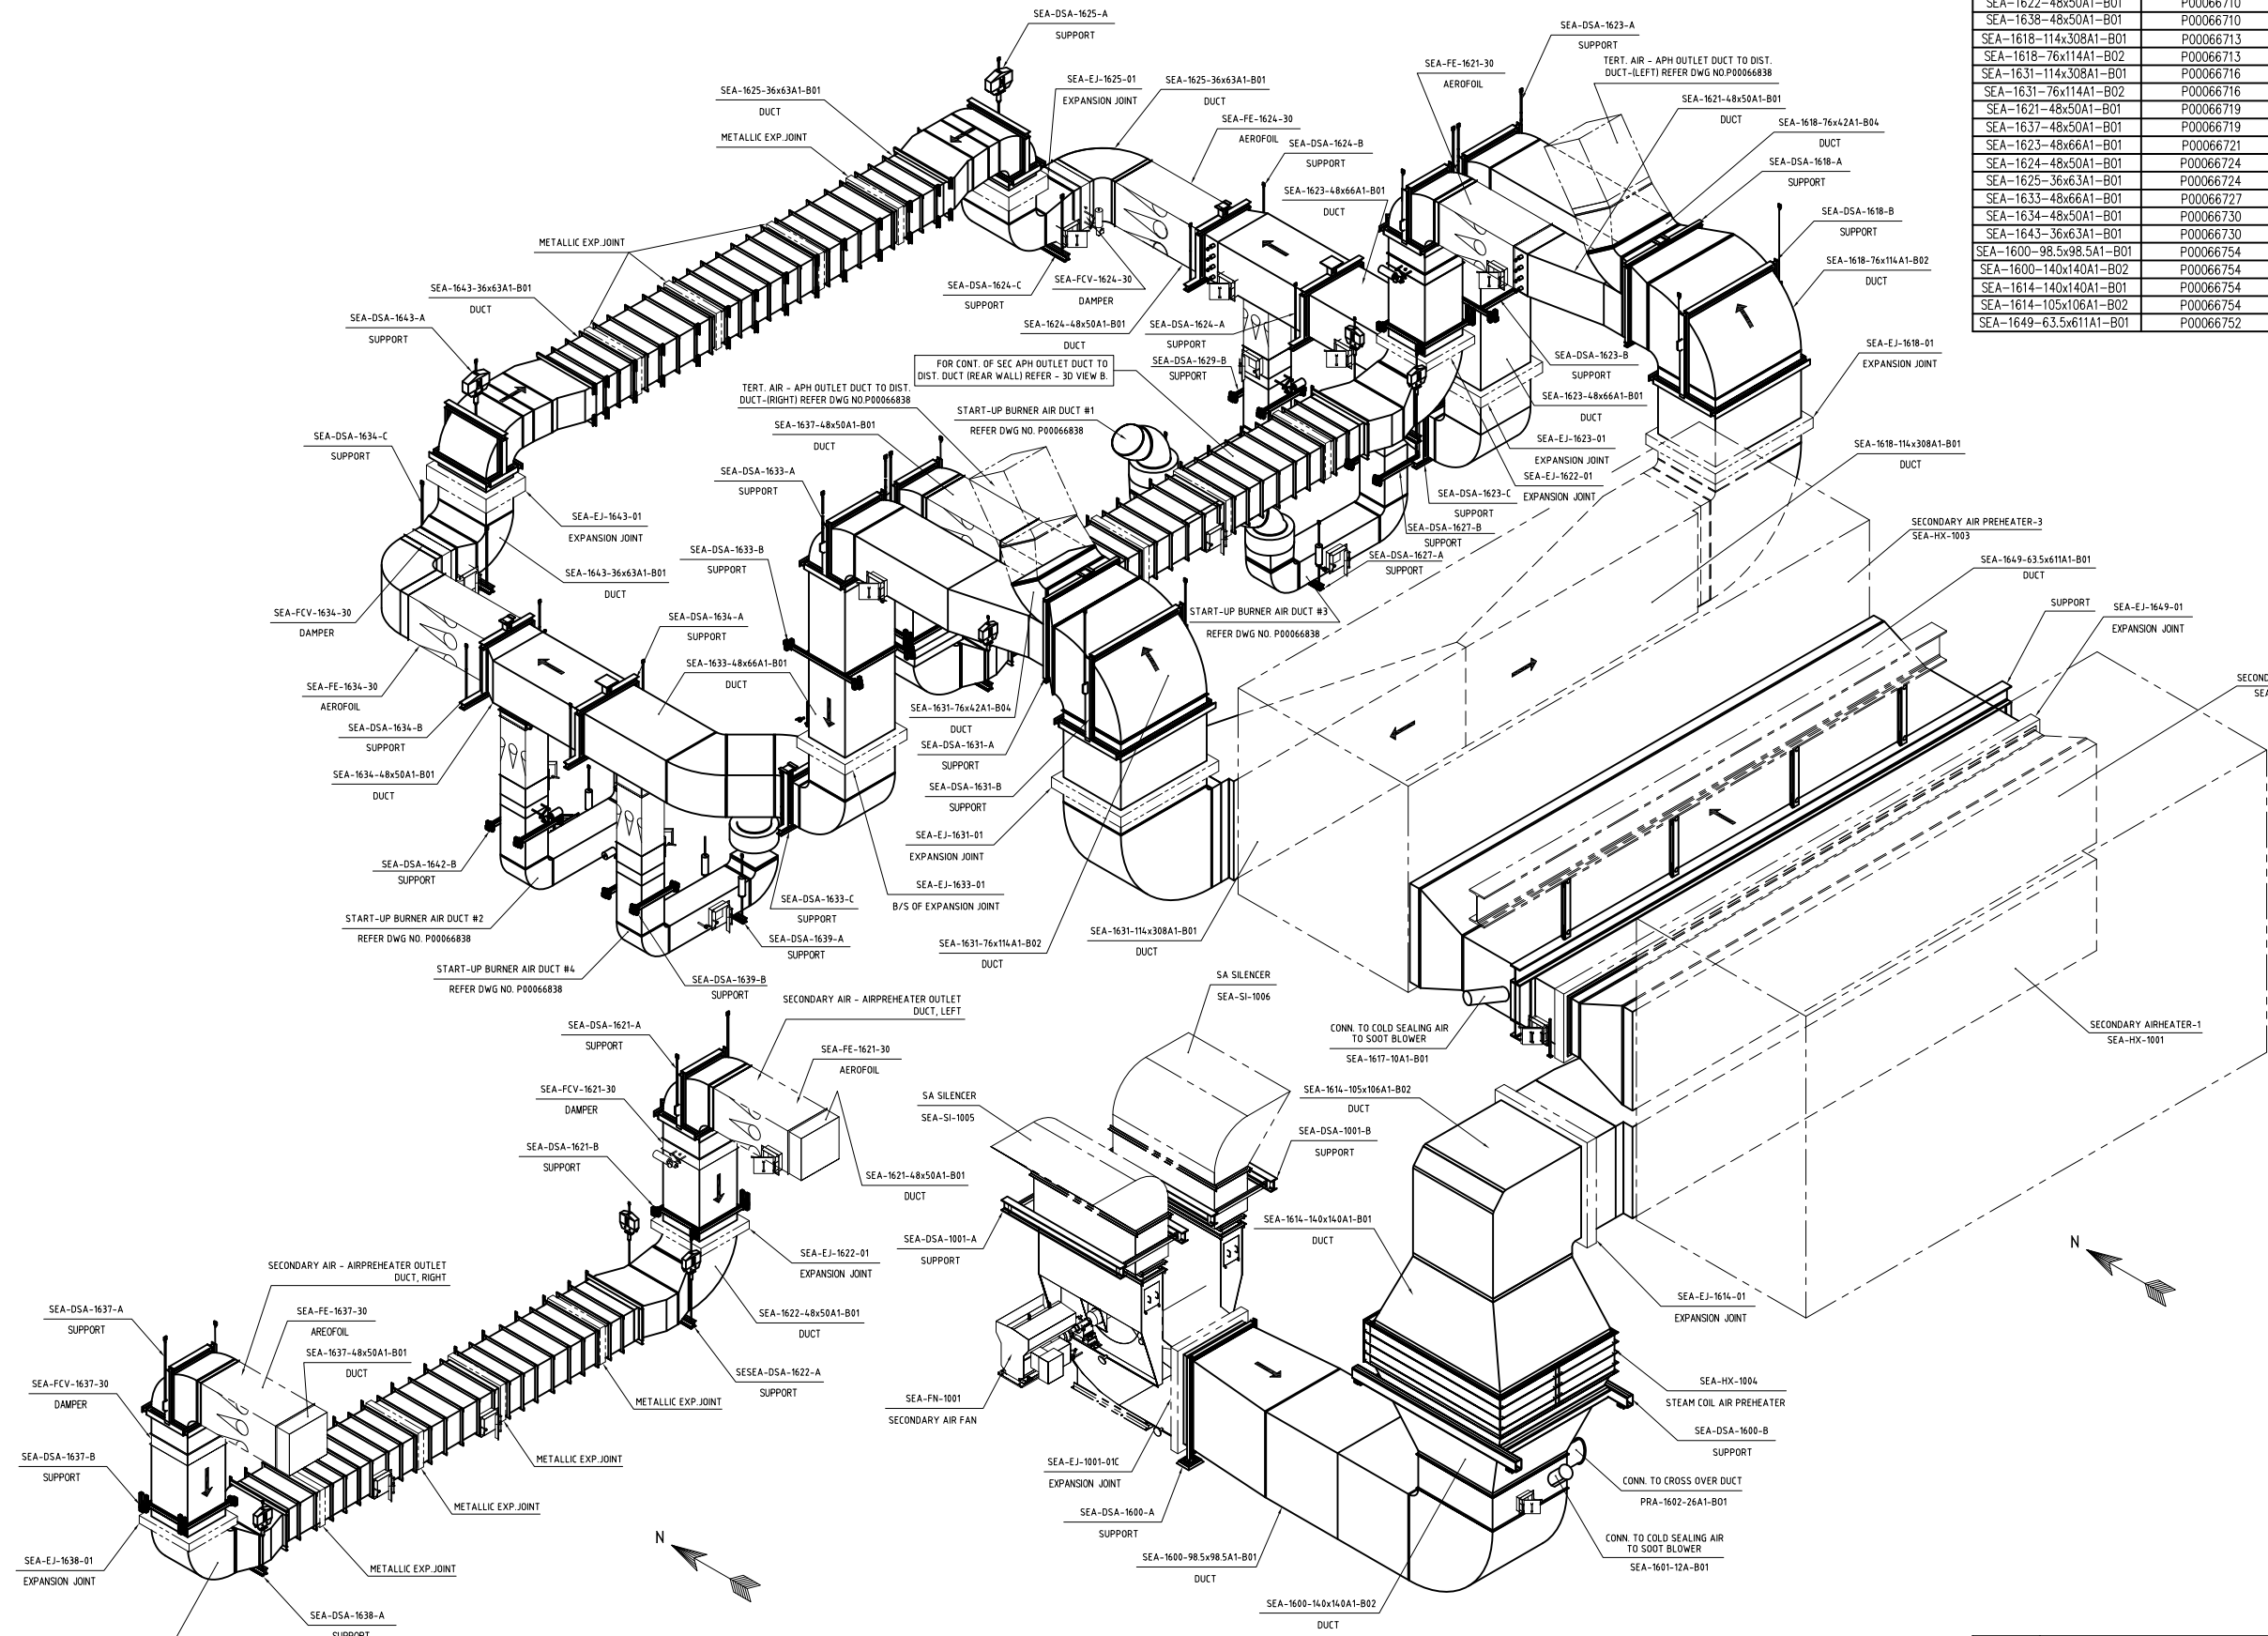

SECONDARY AIR DUCT - REAR WALL DISTRIBUTION DUCT & AIRPREHEATER
OUTLET DUCT TO DIST DUCT REAR WALL
3D VIEW B

SECONDARY AIR DUCT
3D VIEW A

		<small>This document is the exclusive intellectual property of Metso Corporation and/or its subsidiaries and is furnished solely for the use and maintenance of the specific project. The use of this document for any other project or purpose is prohibited. The document or its information shall not be reproduced, copied or disclosed in a third party without prior written consent of the company.</small>	
190022 190520 Certified for Construction	GREC LLC - Gainesville FL SECONDARY AIR DUCT SYSTEM GENERAL ARRANGMENT	P00066837	0

M014200-BLRM00686 S01 R0

AutoCAD DRAWING
DO NOT REVISE MANUALLY