


211175-01-D803-02 7 6 5 4 3 2 1

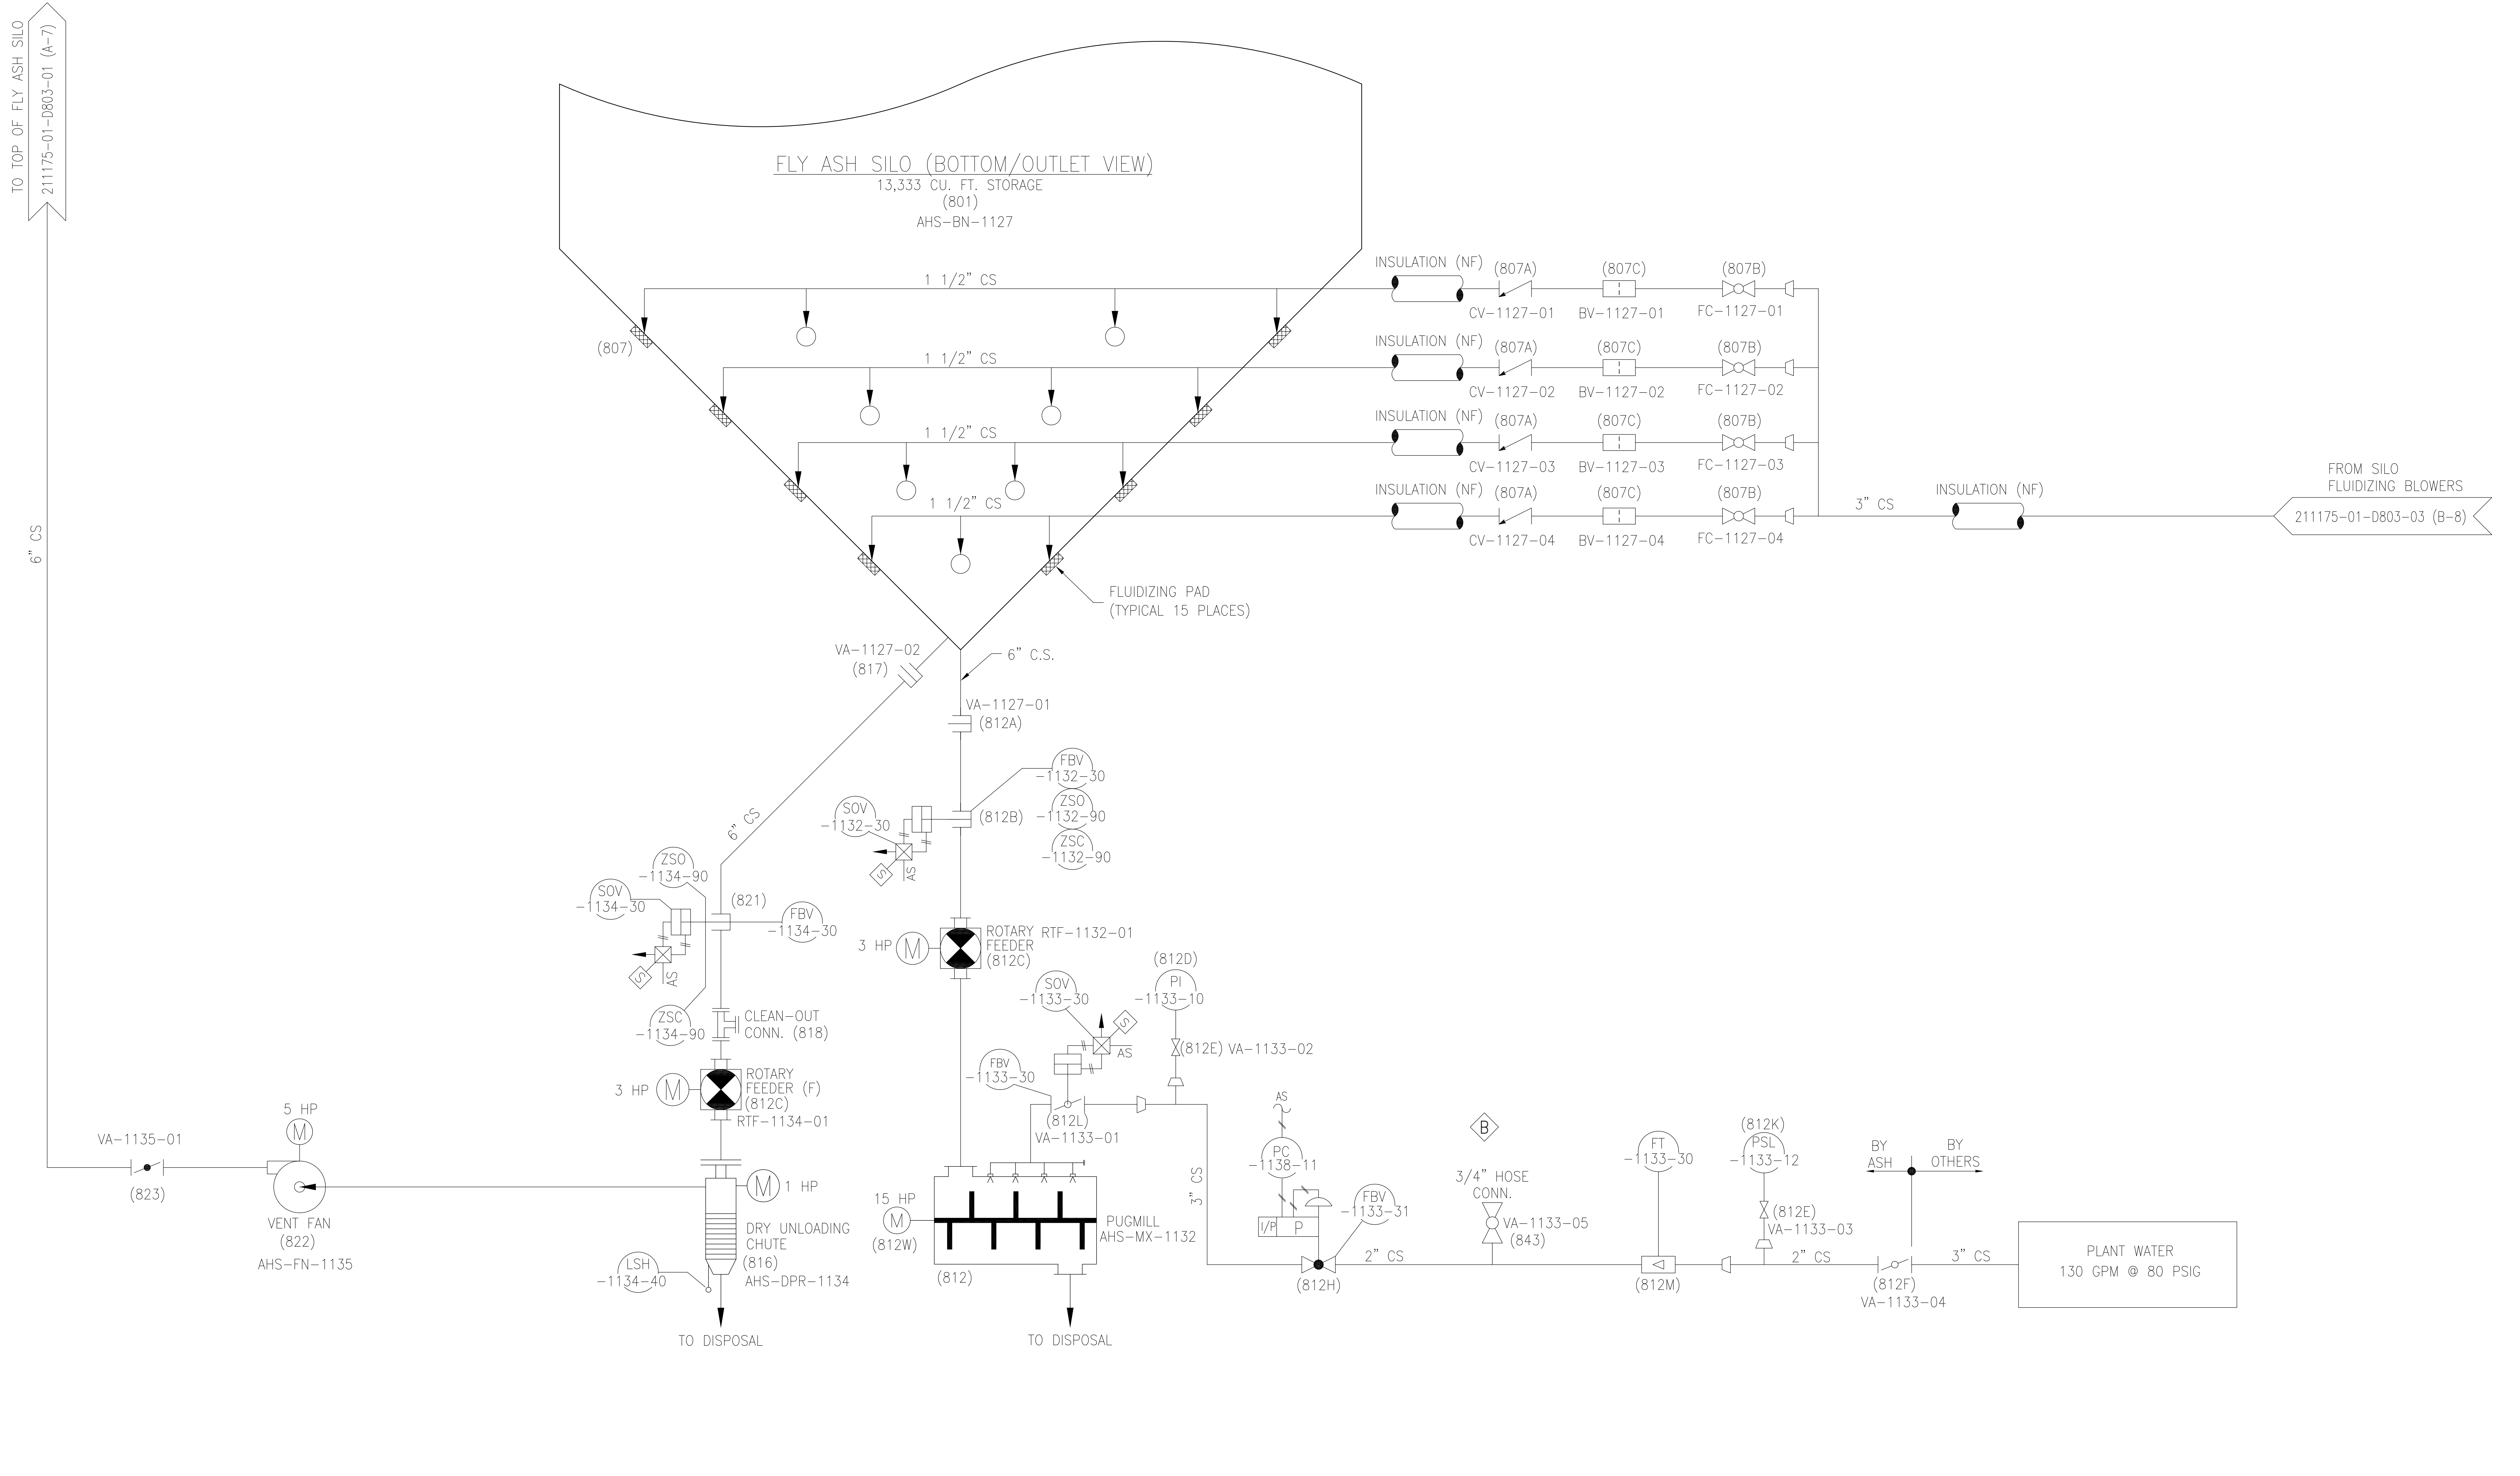

REFERENCES	E-7761	P & ID LEGEND		DRAWN BY	PMD	9/30/11	<b>Allen-Sherman-Hoff</b> A Division of Diamond Power International, Inc. EXTON, PENNSYLVANIA, U.S.A.	P & ID <b>FLY ASH HANDLING SYSTEM</b> FAGEN, INC. GAINESVILLE RENEWABLE ENERGY CENTER GAINESVILLE, FLORIDA	SCALE	NONE
	DWG.	TITLE	REV.		DATE	REV. BY			CKD. BY	ENG. APP.
REVISIONS	C	11/23/11	NAC	PHD	PKH	RTS	REVISED PER CUSTOMER M/P	© 2010 DIAMOND POWER INTERNATIONAL, INC. ALL RIGHTS RESERVED. THIS DRAWING IS THE PROPERTY OF DIAMOND POWER INTERNATIONAL, INC. (DPI) AND ITS USE IS GOVERNED BY THE TERMS AND CONDITIONS OF THE CONTRACT FOR WHICH IT WAS CREATED. DPI GRANTS A NON-EXCLUSIVE LICENSE TO USE, REPRODUCE AND DISTRIBUTE THIS DRAWING SOLELY FOR THE MAINTENANCE, REPAIR AND OPERATION, AND FOR SOLICITING BIDS FOR THE ERECTION OF THE EQUIPMENT DISCLOSED HEREIN.	DWG.	211175-01-D803-02
	B	11/07/11	AES	PMD	RJR	RTS	ADDED 3/4" HOSE CONNECTION		REV	C
	A	10/17/11	NAC	RJR	RJR	RTS	REVISED PER CUSTOMER M/P		SHEET 2 OF 3	
REVISION RECORD										

8 7 6 5 4 3 2 1